

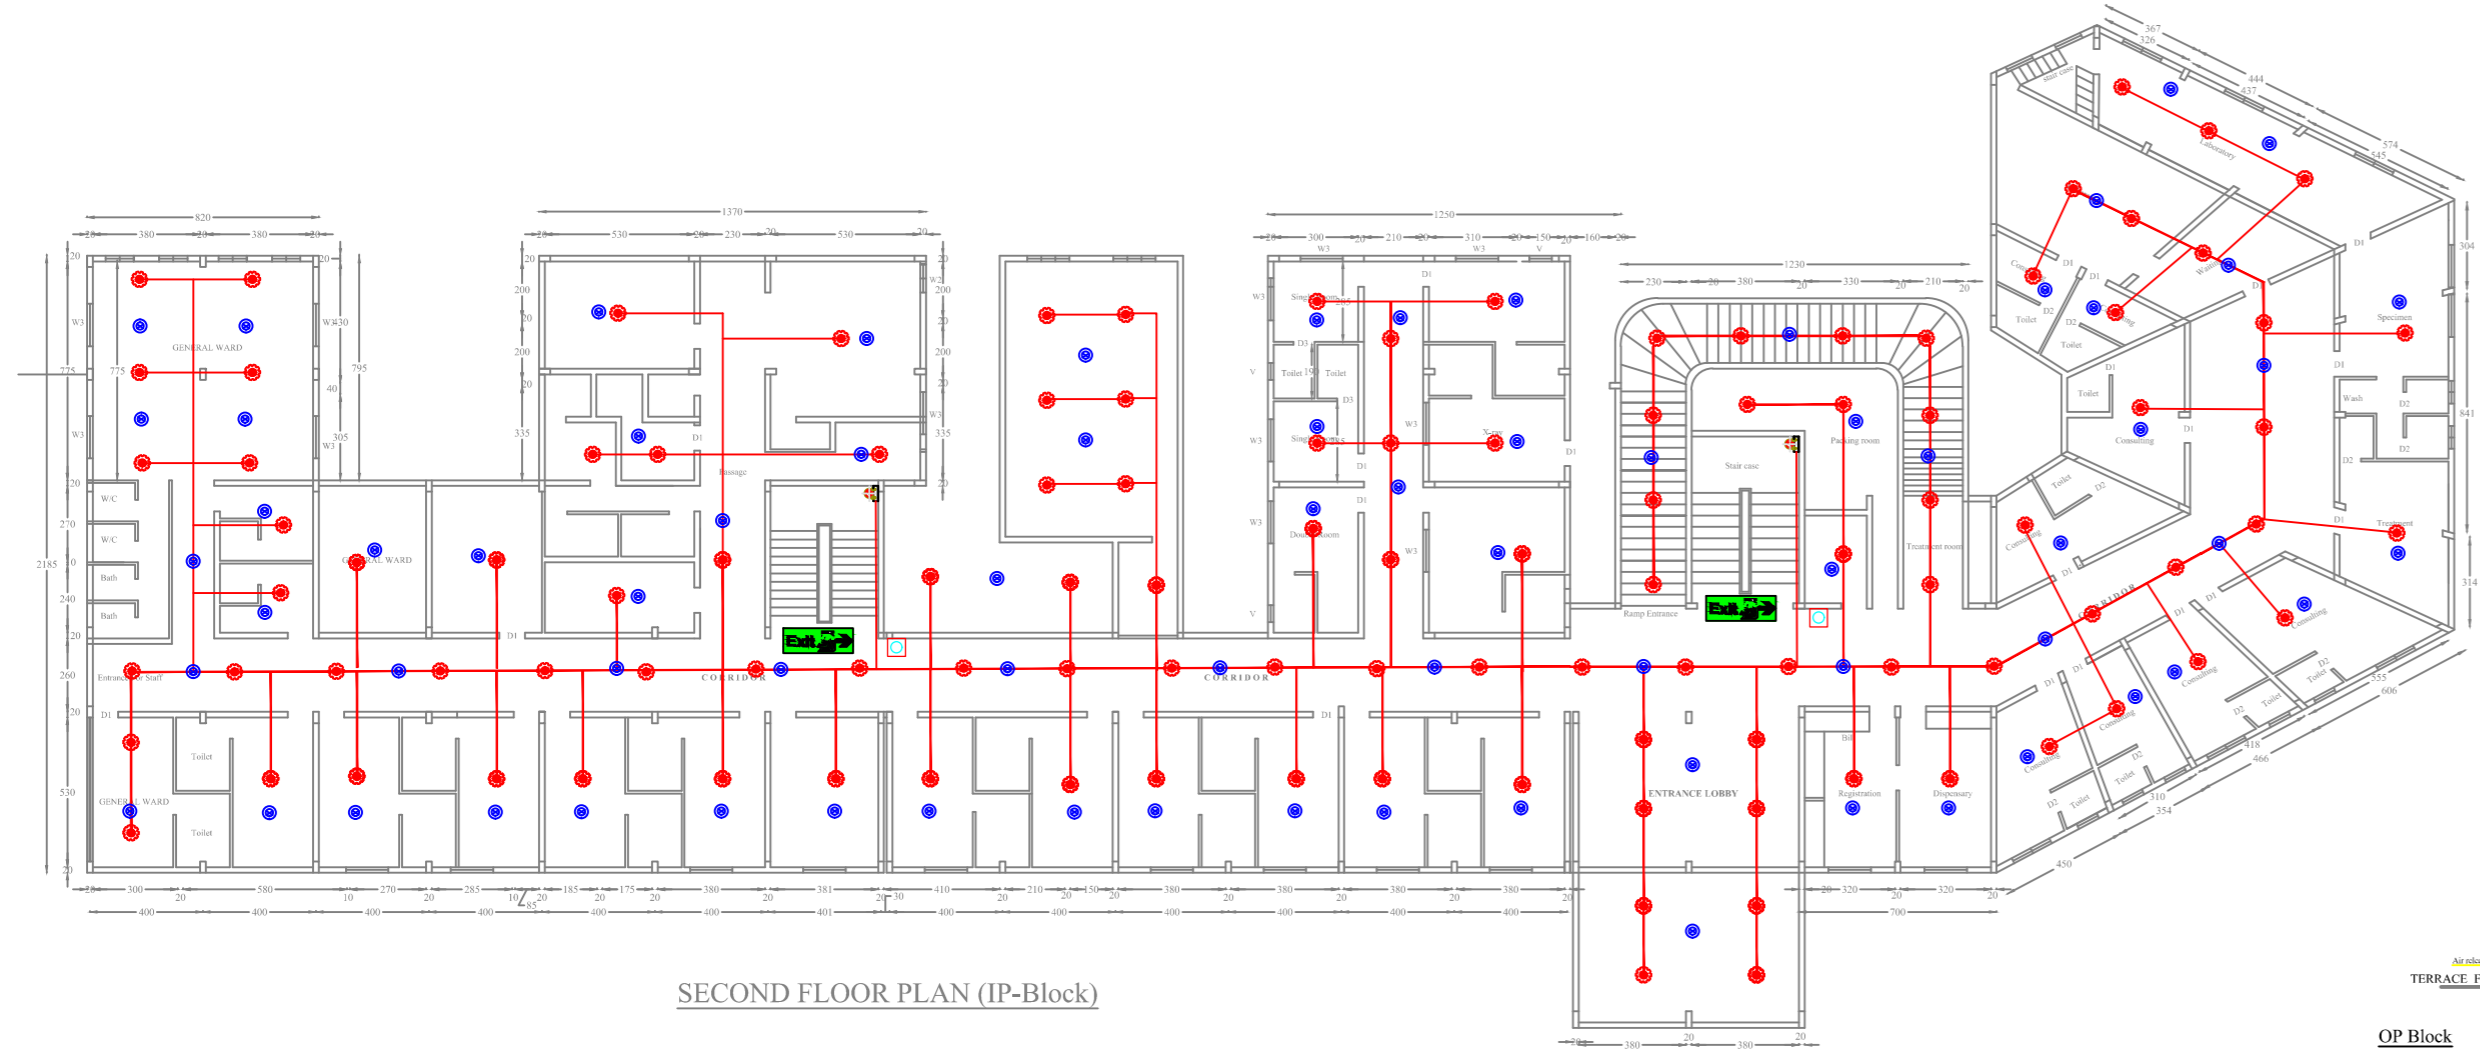
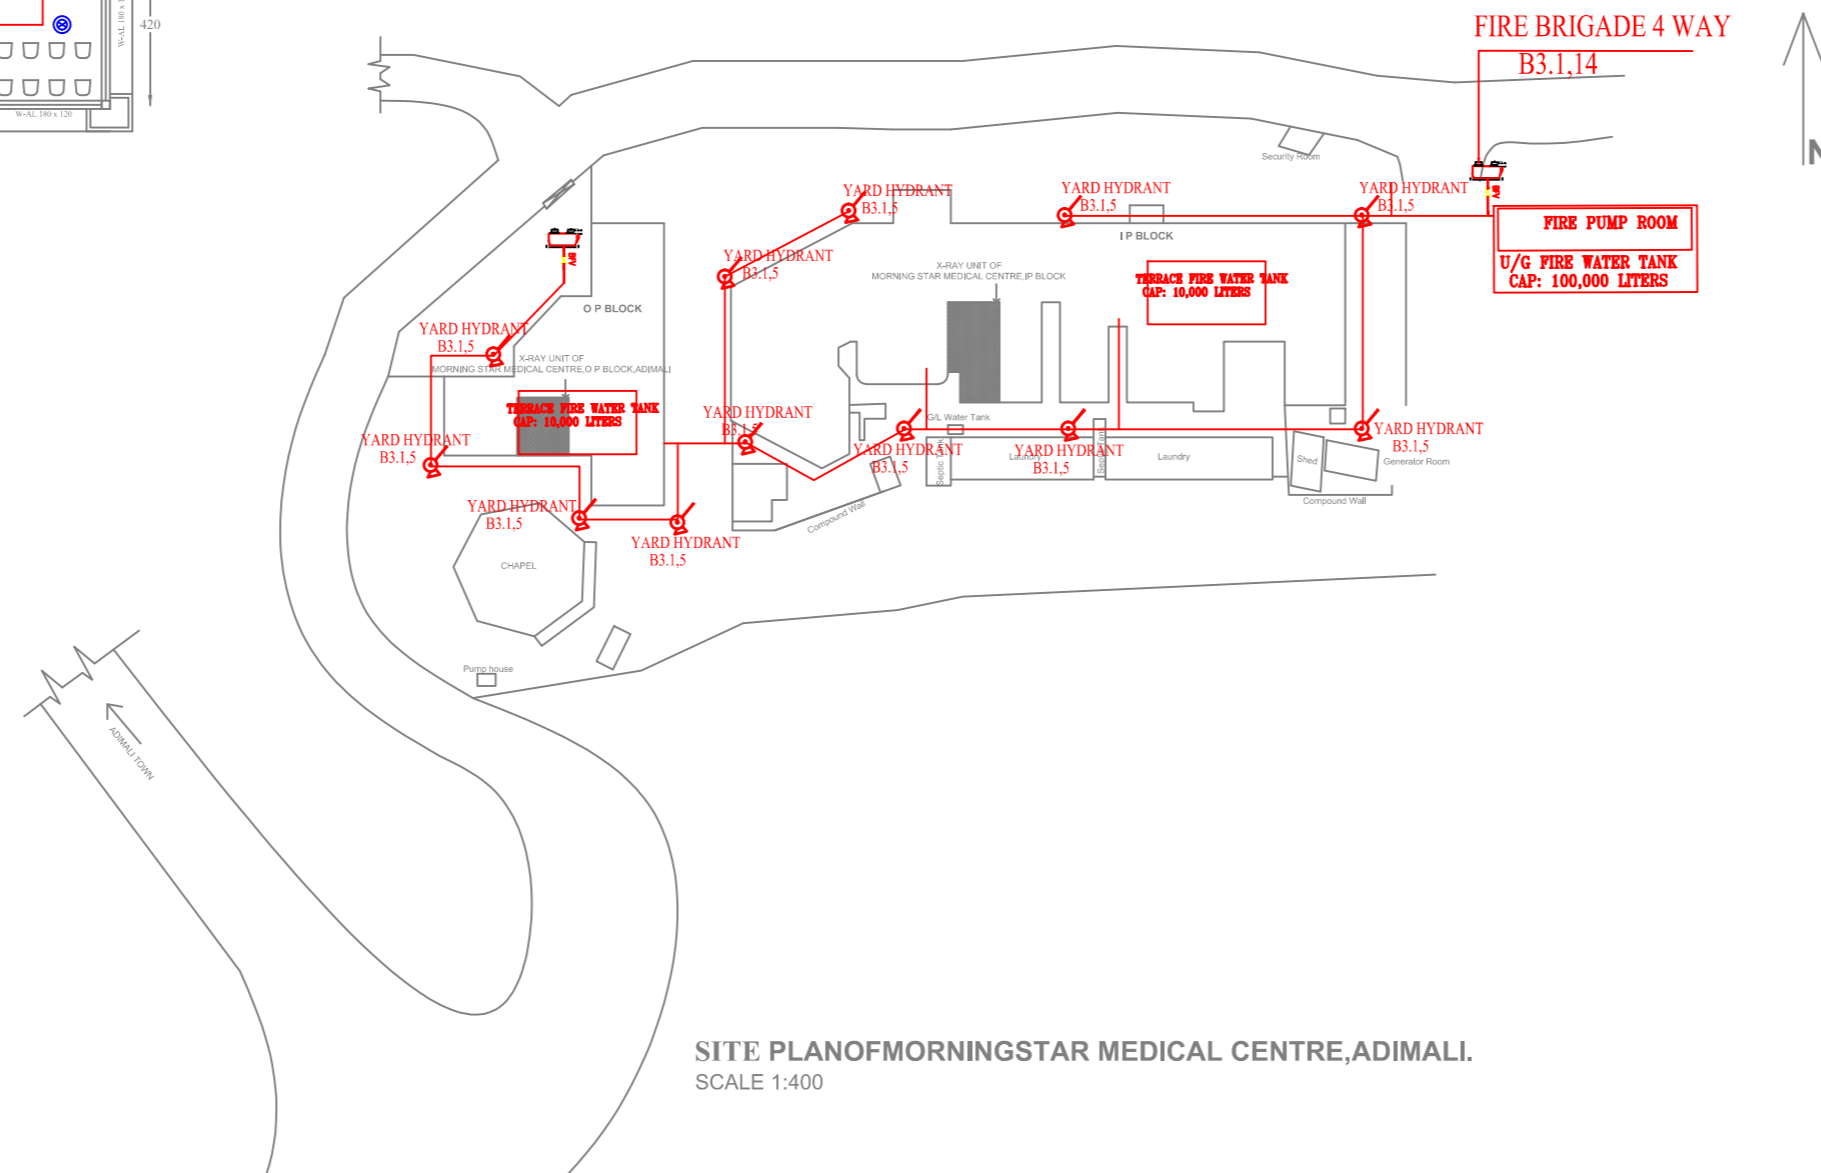


# Sample Fire Drawing For Morning Star hospital, Adimaly

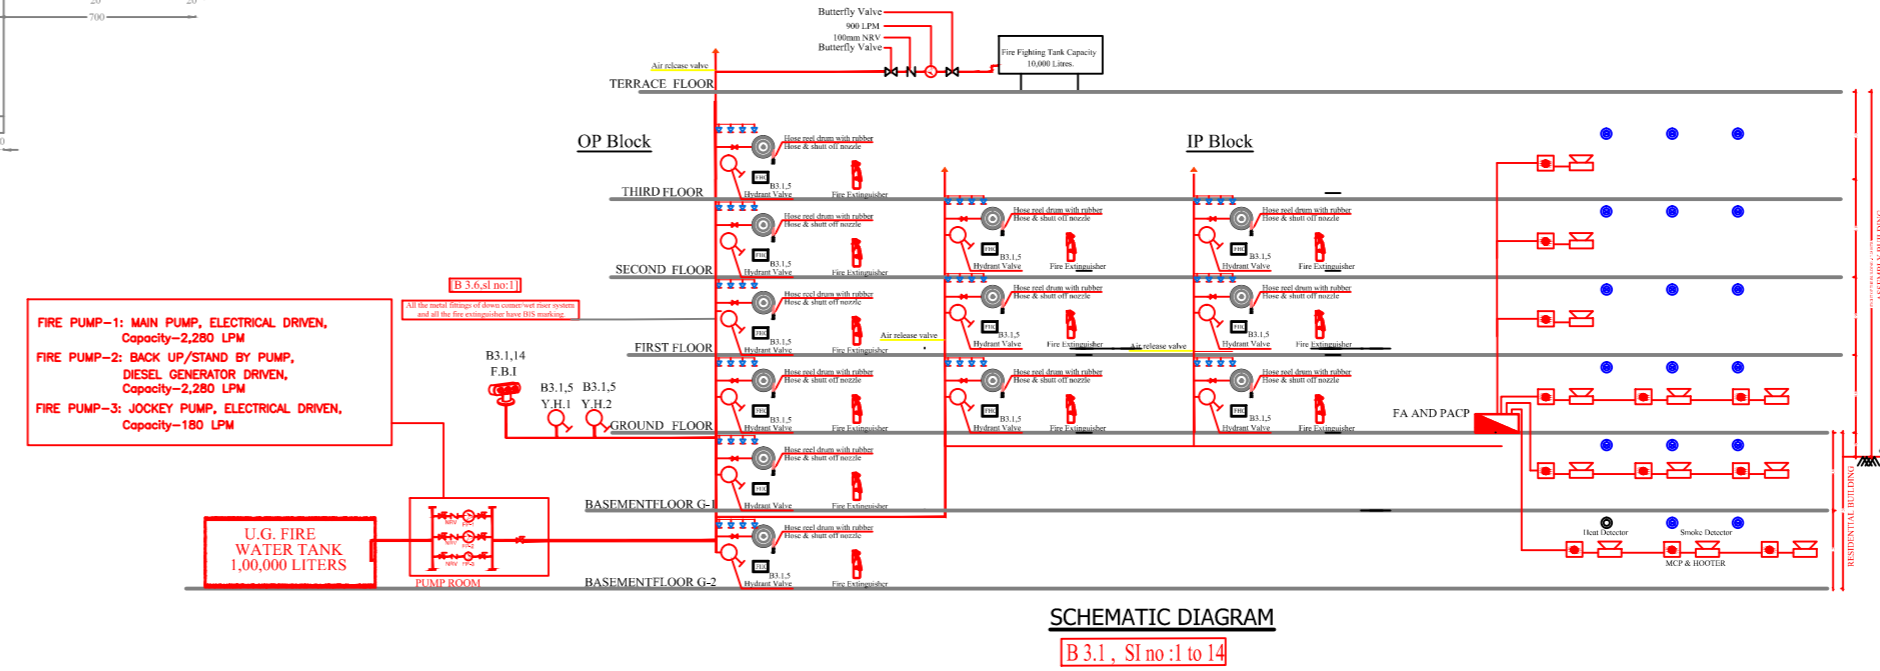

All floors are similar fire fighting system.  
Fire extinguishers and fire alarm systems additional

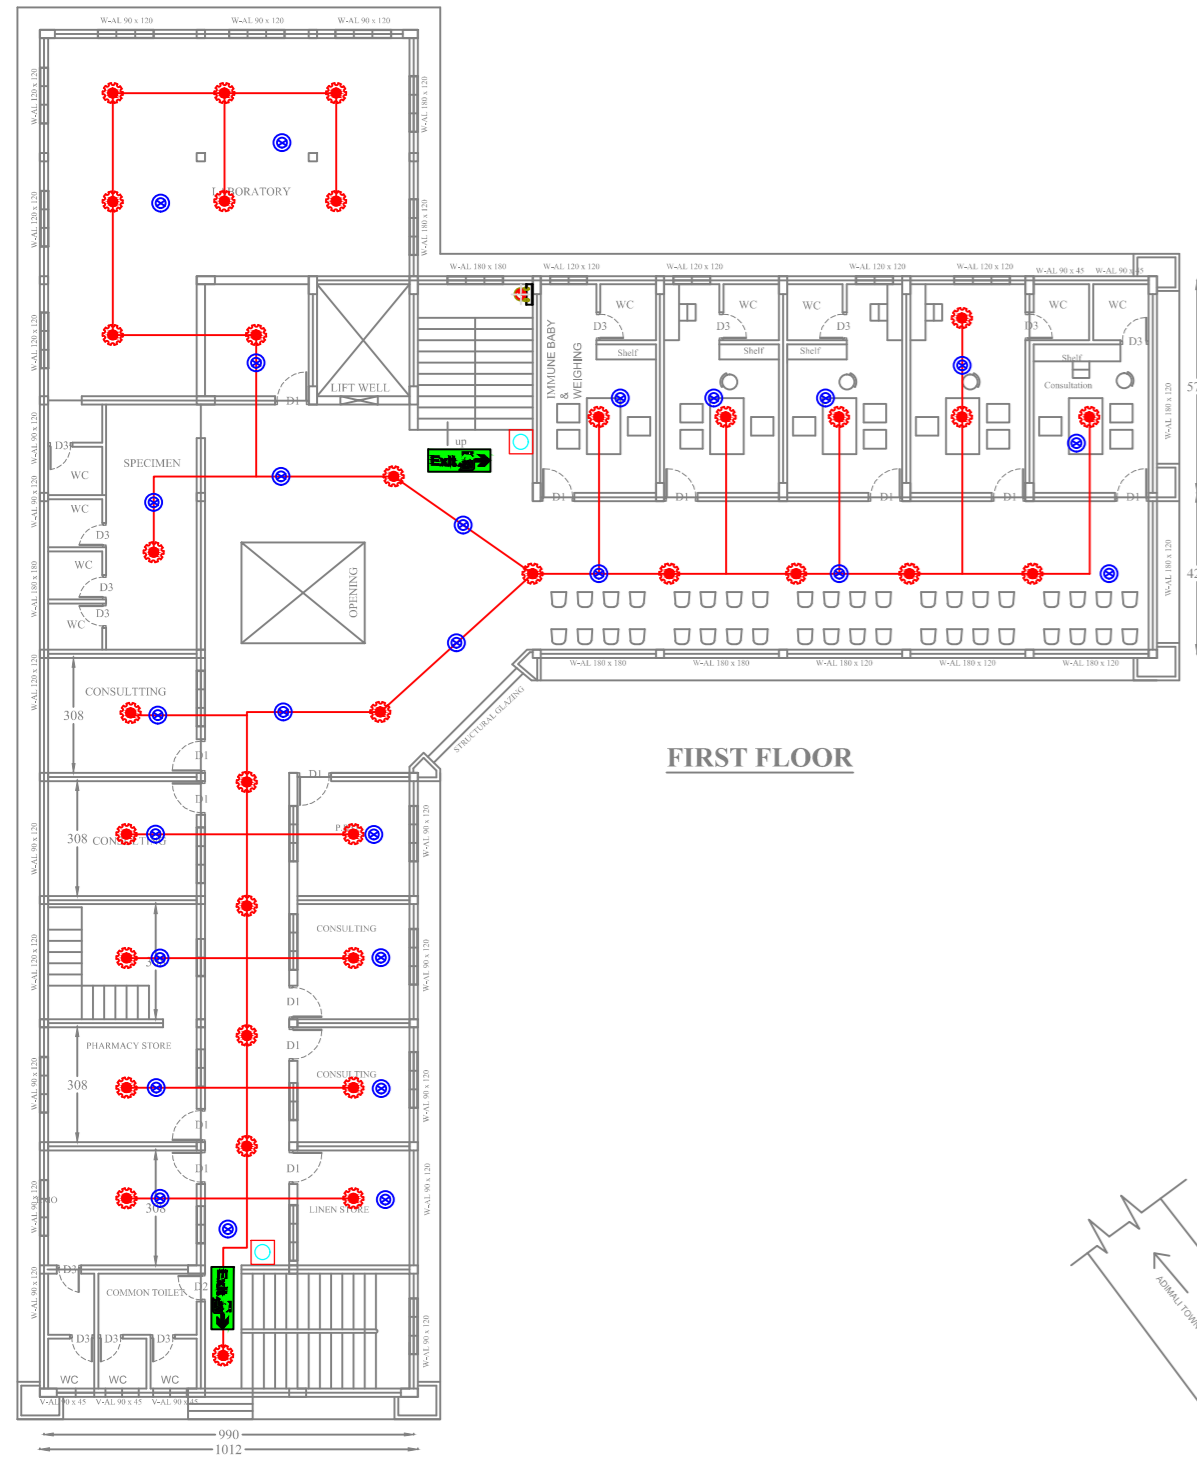

FIRE SAFETY CLEARANCE FOR SITE	
LEGEND	
SYMBOL	DESCRIPTION
	FIRE EXTINGUISHER
	EMERGENCY LIGHTING
	SPRINKLER SIDE WALL
	SPRINKLER PENTENT
	WET RISER
	HYDRANT VALVE
	HOSE
	BRANCH PIPE
	HOSE REEL DRUM
	FIRE ALARM PANEL
	MCP
	HOOTER
	EXTINGUISHER
	FIRE BRIGADE INLET
	BFV, NRV
	SPRINKLER BULB - 68 °C
	900 LPM PUMP
	HOSE BOX
	SIGNAGE - FIRE
	FIRE EXIT - PHOTO LLUMINESCENT
	EXIT - PHOTO LLUMINESCENT
	PUBLIC ADDRESS SYSTEM
	SMOKE DETECTOR

PLOT DETAILS A.2.1 TO 5	
SURVEY NO.	
VILLAGE	
TALUK	
DISTRICT	
PANCHAYATH	

PROJECT :	MORNING STAR HOSPITAL AT ADIMALY	
CLIENT:	A.1.1,2	
FIRE PROTECTION BY:	 ENGINEERS & CONTRACTORS P.P ROAD, KUMBANI, PALA, KOTTAYAM DIST, KERALA, PIN - 686579 PH : 949 7586 904, 949 5351 961 EMAIL : avemarapala@gmail.com	
DRAWING NO :	FF / FINAL - 1302 / 2017 / FFS / 01	
REV: R 00	SCALE: 1 : 100	DATE: 21.02.2017
DRAWN	CHECKED	APPROVED
Abijith	Sajna	Jostine

Title  
**FIRE FIGHTING DRAWINGS**

Sheet No.